



File Name: A1.dwg | BY: Daniel | DATE: October 27, 2014 - 2:45PM

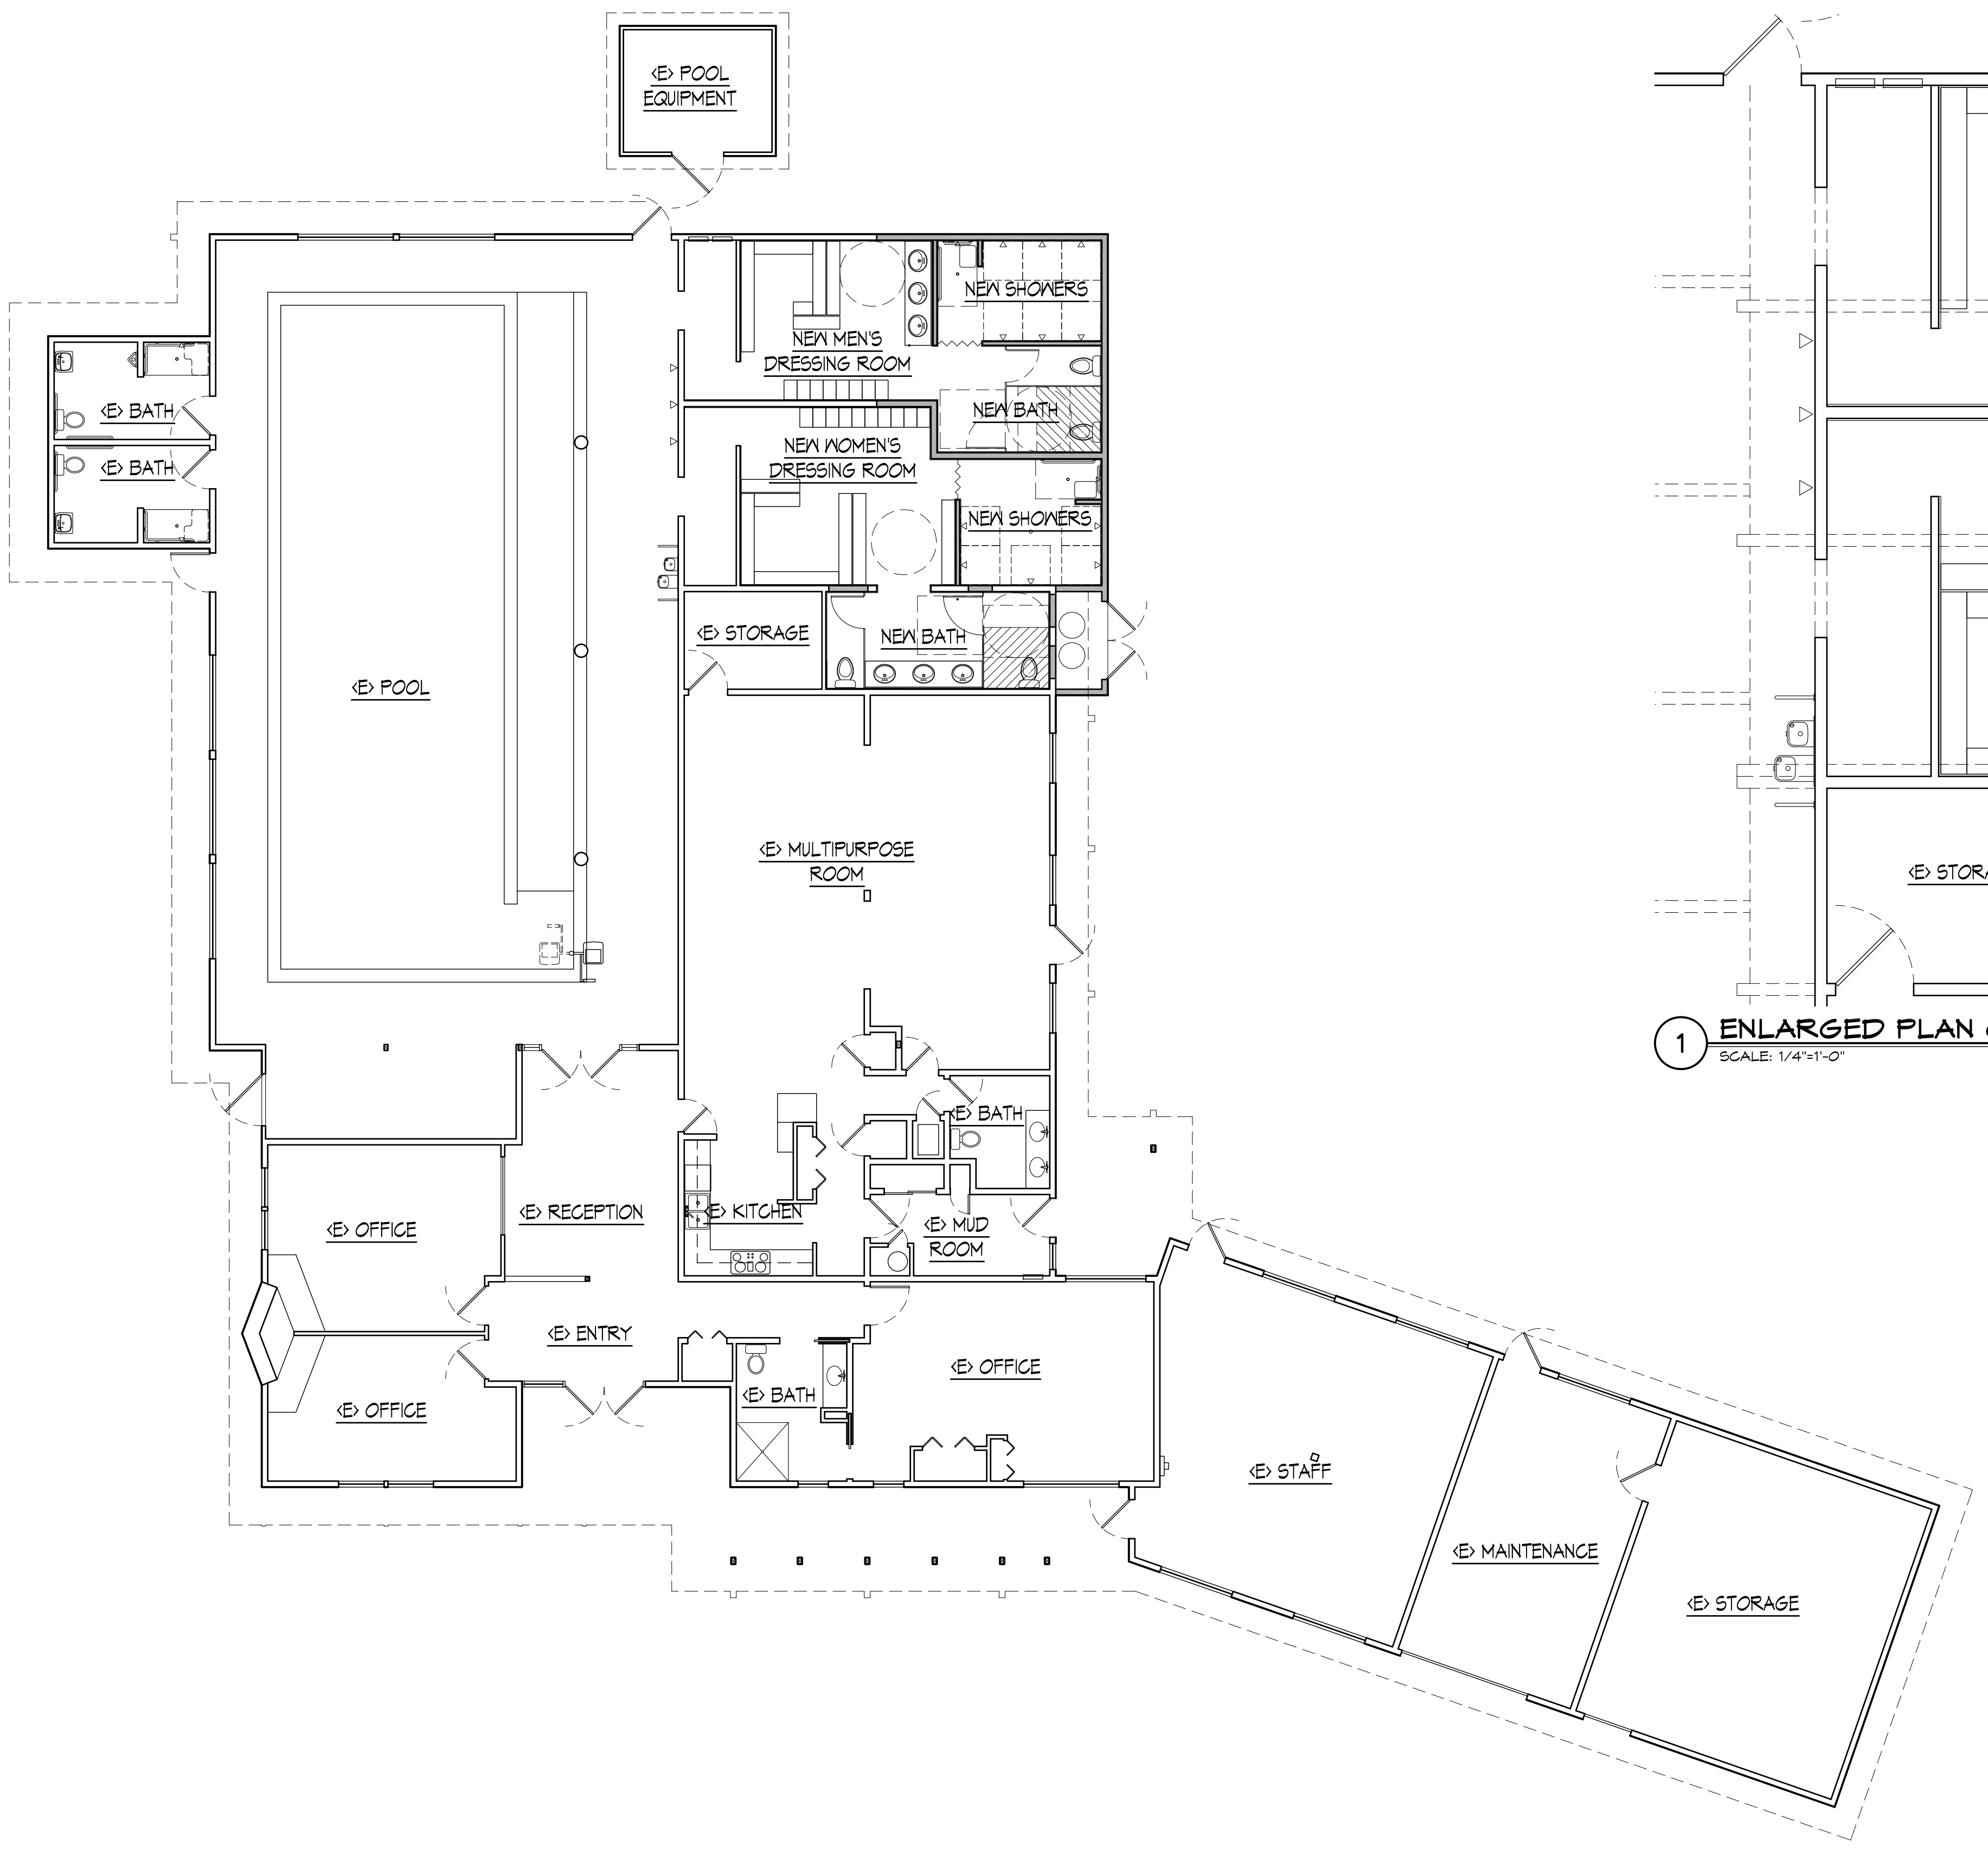


2 OVERALL FLOOR PLAN
SCALE: 1/8"=1'-0"

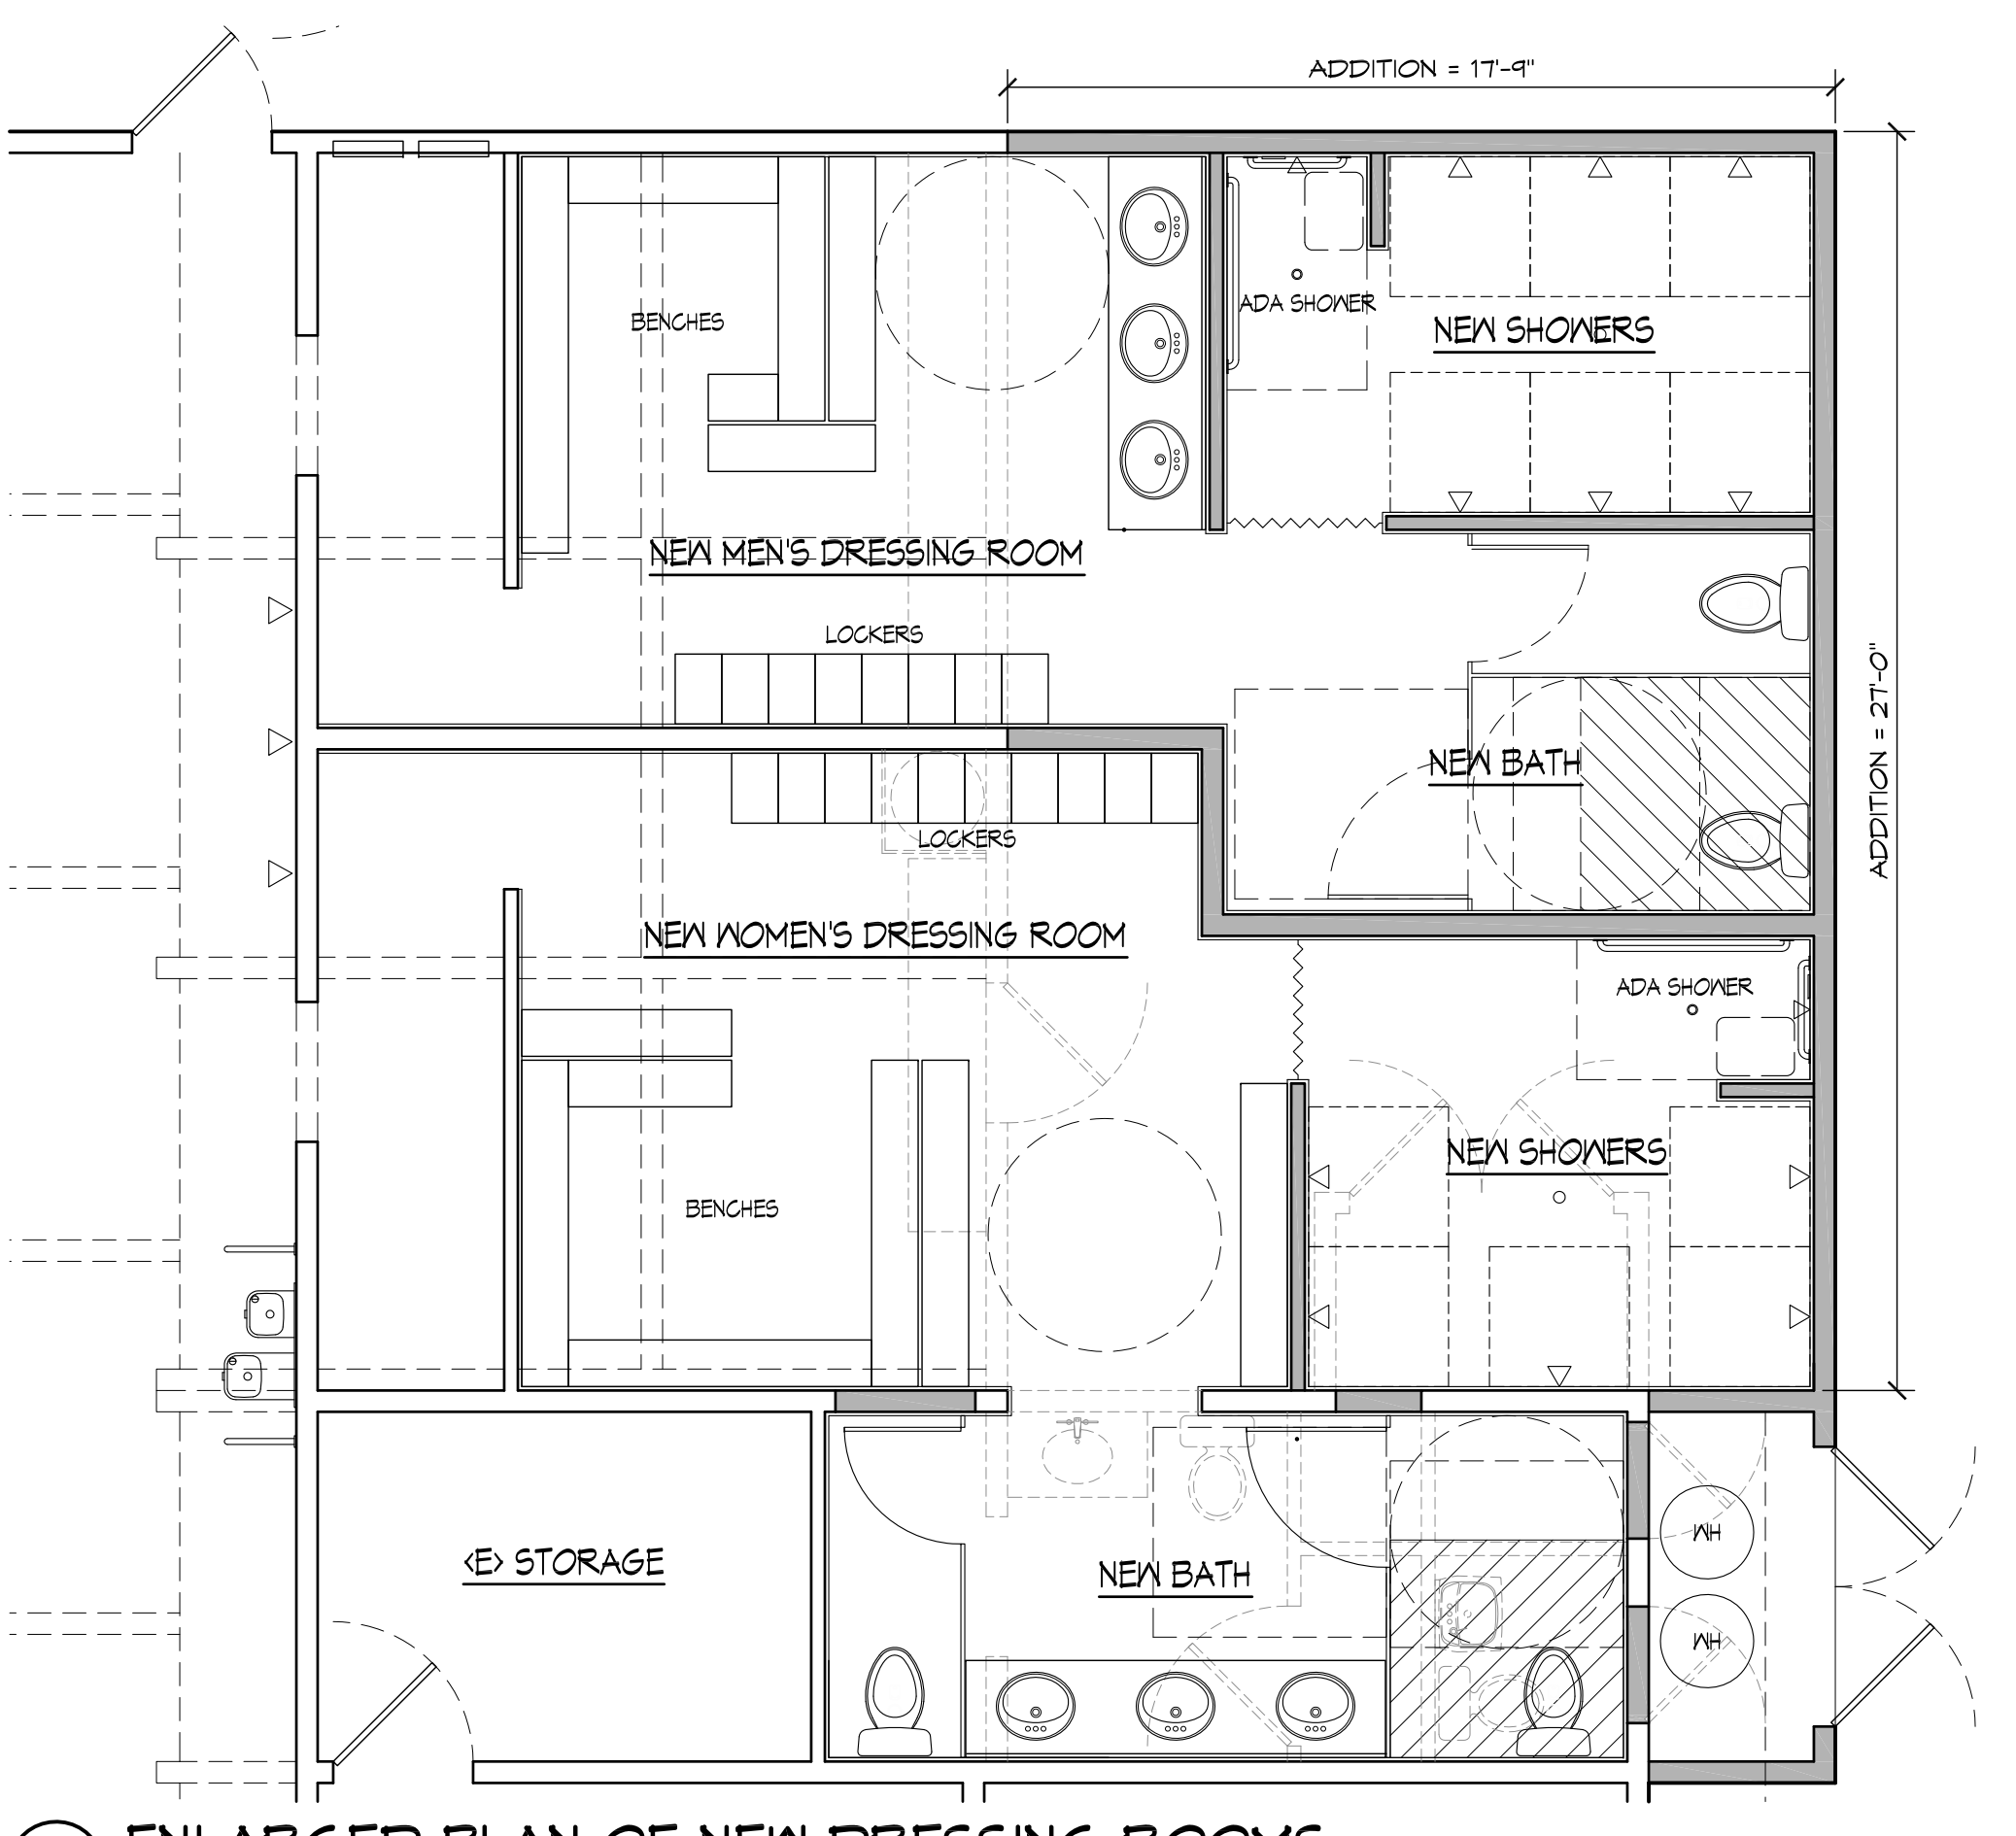

1 ENLARGED PLAN OF NEW DRESSING ROOMS
SCALE: 1/4"=1'-0"

REVISIONS	
DATE	BY

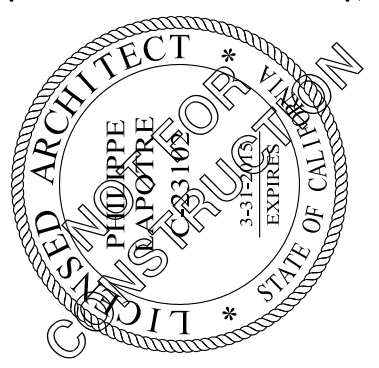

PHILIPPE LAPOTRE ARCHITECT
 2724 MYRTLE AVE. SUITE C EUREKA, CA 95501
 TEL: (707) 442-8872 FAX: (707) 442-8872
 WWW.PLARCHITECT.COM

PHASE 2 EXPANSION FOR VECTOR AQUATIC CENTER
 9289 EDGEWOOD ROAD EUREKA, CALIFORNIA
 APN: 01B-142-0394

ALL DESIGNS, CONCEPTS, IDEAS AND ARRANGEMENTS DEPICTED WITHIN THESE DRAWINGS AND SPECIFICATIONS ARE THE SOLE PROPERTY OF THE ARCHITECT. ANY REUSE OF THIS DRAWING OR ANY PART OF IT FOR ANY OTHER PURPOSE WHATSOEVER SHALL NOT BE USED WITHOUT THE WRITTEN CONSENT OF THE ARCHITECT.

DATE: Oct 27, 2014
 JOB # 1306.00
 FILE: A1.dwg
 DRAWN: D BRADEN